




NOTE:
DB's in Lobby and open area
should be concealed & aluminum
cover protection with lock required.

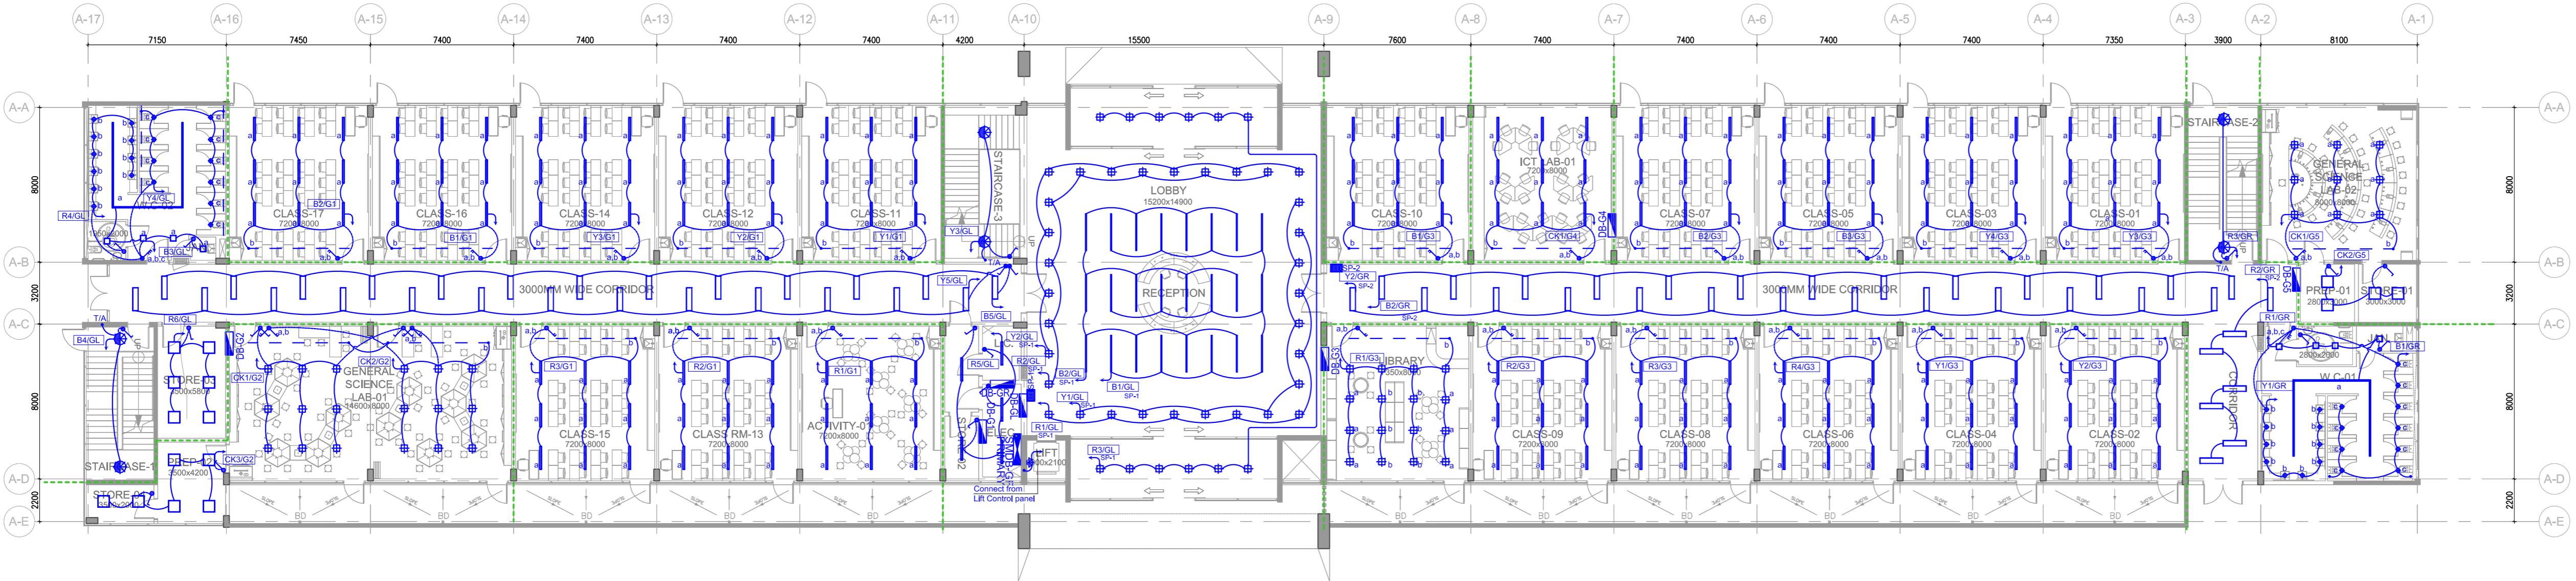

BLOCK A - GROUND FLOOR (PRIMARY BLDG.)
1 : 200

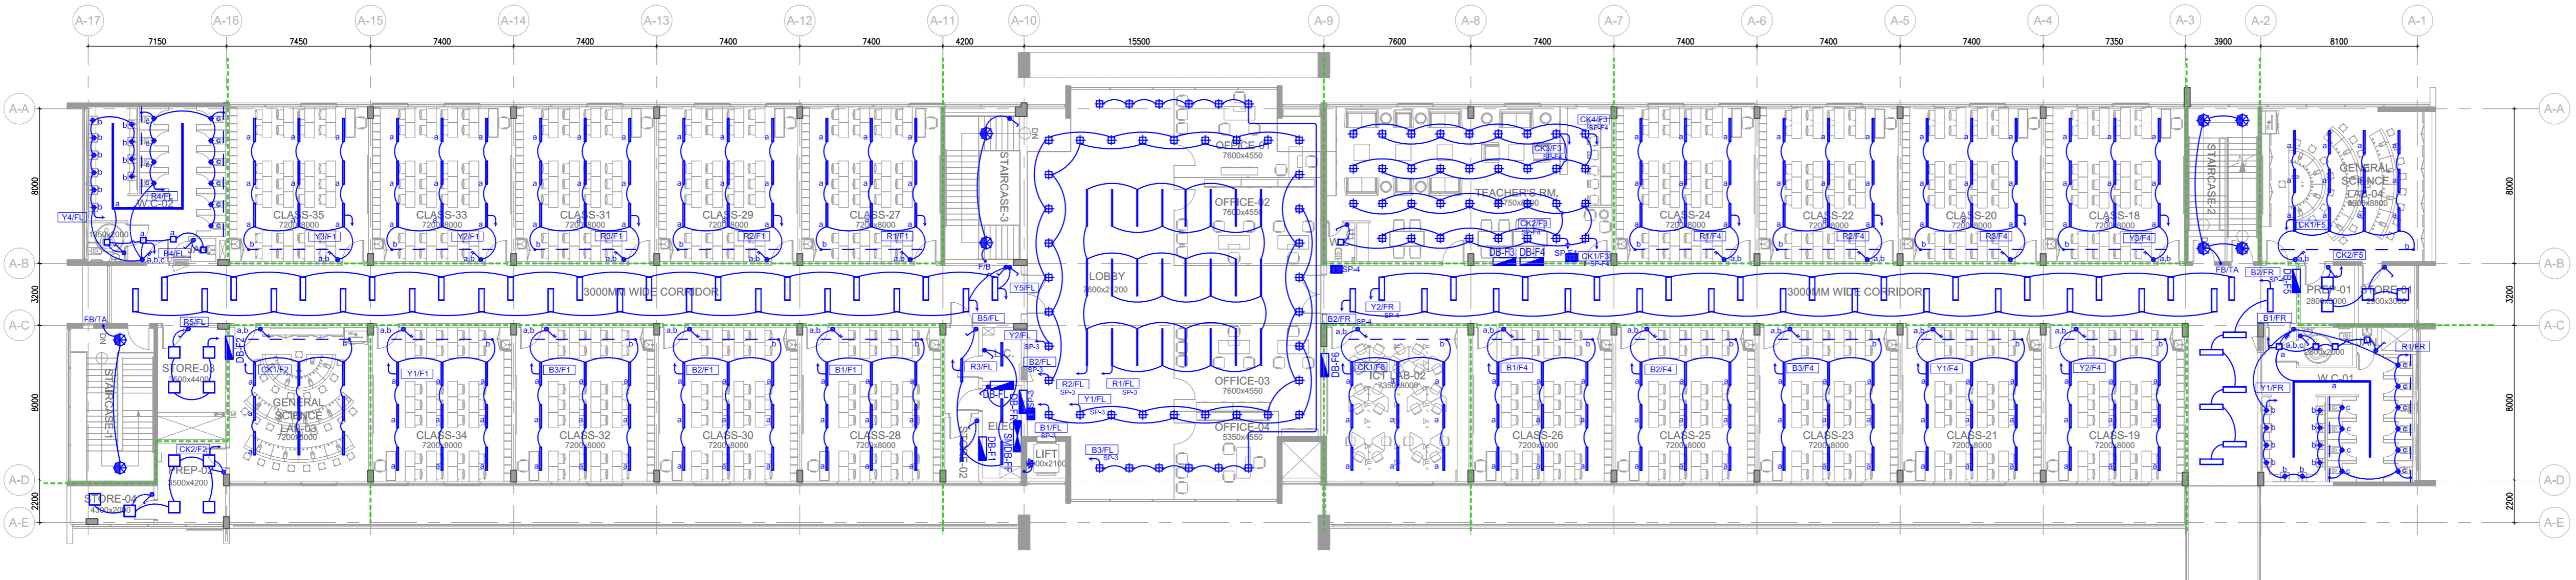


BLOCK A - FIRST FLOOR (PRIMARY BLDG.)
1 : 200

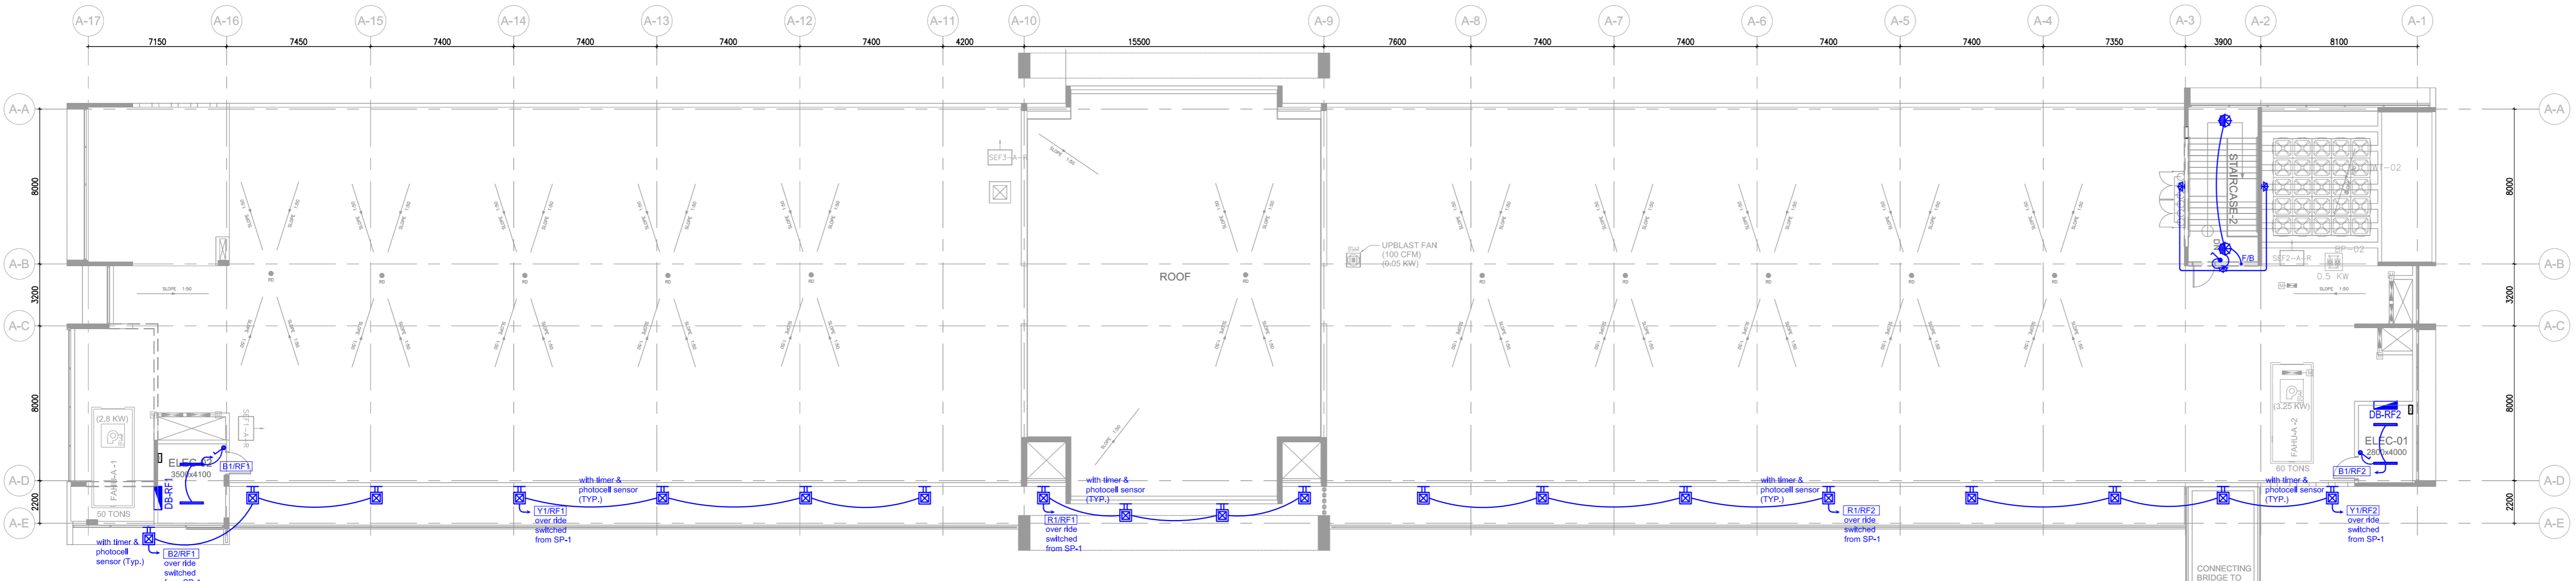

BLOCK A - ROOF FLOOR (PRIMARY BLDG.)
1 : 200

GENERAL NOTES:
• ALL DIMENSIONS ARE IN MILLIMETRES UNLESS OTHERWISE STATED.
• DO NOT SCALE THE DRAWING FOLLOW WRITTEN DIMENSIONS ONLY.
• FOR ALL ABBREVIATION AND SYMBOLS REFER TO SHEET NO : G-103.

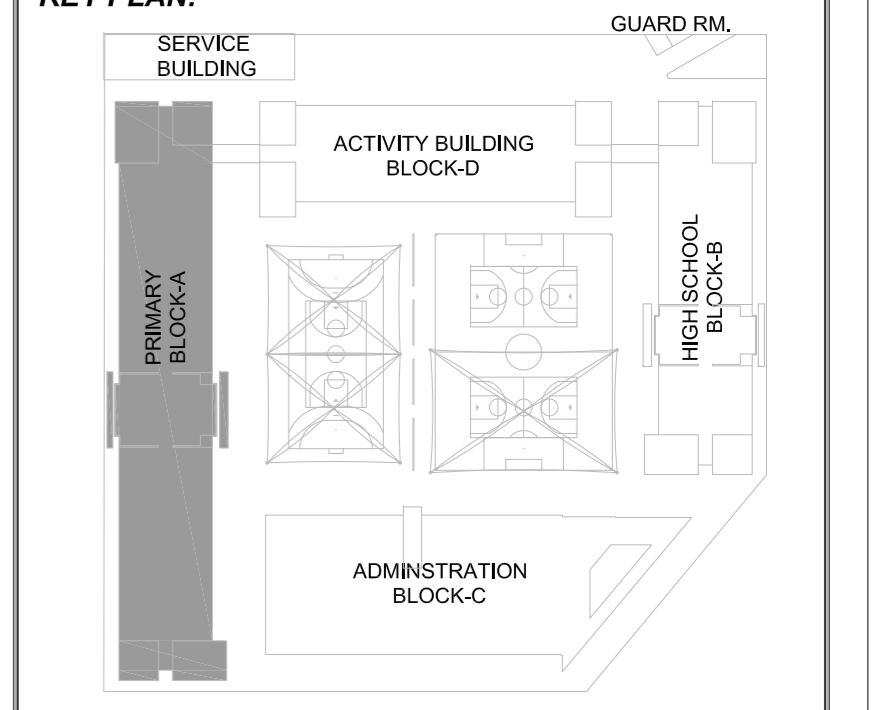

LIGHT FITTING LEGEND (All lights to be LED)

	DOWNLIGHT
	30X30 DOWNLIGHT
	CEILING MOUNTED LIGHT
	60X60 PANEL LED LIGHT
	120X10 LED PANEL LIGHT
	120X30 LED PANEL LIGHT
	150X15 LED PANEL LIGHT
	30X30 PANEL LED LIGHT
	PROJECTOR
	LED STRIP LIGHT
	ONE GANG ONE WAY LIGHT SWITCH
	ONE GANG TWO WAY LIGHT SWITCH
	ONE GANG THREE WAY LIGHT SWITCH
	TWO GANG ONE WAY LIGHT SWITCH
	TWO GANG TWO WAY LIGHT SWITCH
	TWO GANG THREE WAY LIGHT SWITCH
	SWITCH PANEL BOARD
	EXHAUST FAN (WALL TYPE)

NOTE:
For more details of light type & specification please refer to interior ceiling layout drawing

C	16-07-20	REARRANGED DB'S CIRCUIT NAMES (SMDB-FF)	
B	29-06-20	REARRANGEMENT OF ELECTRICAL DESIGN AS PER ARCHITECTURAL AMENDMENTS	
A	02-04-20	ELEC. DRAWING REARRANGED AS PER ARCHITECTURAL AMENDMENTS	
NO.	DATE	REVISION DESCRIPTION	SIGN

CONSULTANT
الاستشاريون للبحث والتطوير والتخطيط العمراني
Development, Research & Urban Planning Consultants LLC
Tel: +971 2 2249422 Fax: +971 2 2249497 P.O. Box: 3477 Fujairah-UAE
E-mail: info@drugulfae.com, www.drugulfae.com, www.facebook.com/druconsultants

STAMP
RUL DIBBA
DIBBA-FUJAIRAH.

PLOT CODE
PLOT NO:1403051

CLIENT
H.H.SHEIKH SALEH BIN MOHAMED BIN HAMAD AL SHARQI

CONTRACTOR
FUJAIRAH NATIONAL CONSTRUCTION & TRANSPORT CO.
FNCT P.O. BOX 91, FUJAIRAH-U.A.E. TEL: 01746 224 154, FAX: 01746 223 1772

PROJECT NAME
G+2 SCHOOL BLDG.-2, PLOT NO.-5001388, AL NAHDAH, DIBBA

DRAWING TITLE
BLOCK A - PRIMARY BUILDING LIGHTING LAYOUT

PROJECT NO.	DISCIPLINE	CHART NO.	DRAWING STATUS	REV.
1 8 1 0	E	1 01 A	F	C

ARCHITECT
J.K.M.

STR. ENGINEER
A.A.H.

SCALE 1 : 200 **DATE**

THIS DRAWING IS COPYRIGHT TO DRU
File: \server\Map\DRG\113\14\Draw_School\2020\10\Electrical\Primary Bldg\Lighting\101 A (GF FF RF) LIGHT.dwg