



BLOCK A - GROUND FLOOR (PRIMARY BLDG.)
1 : 200

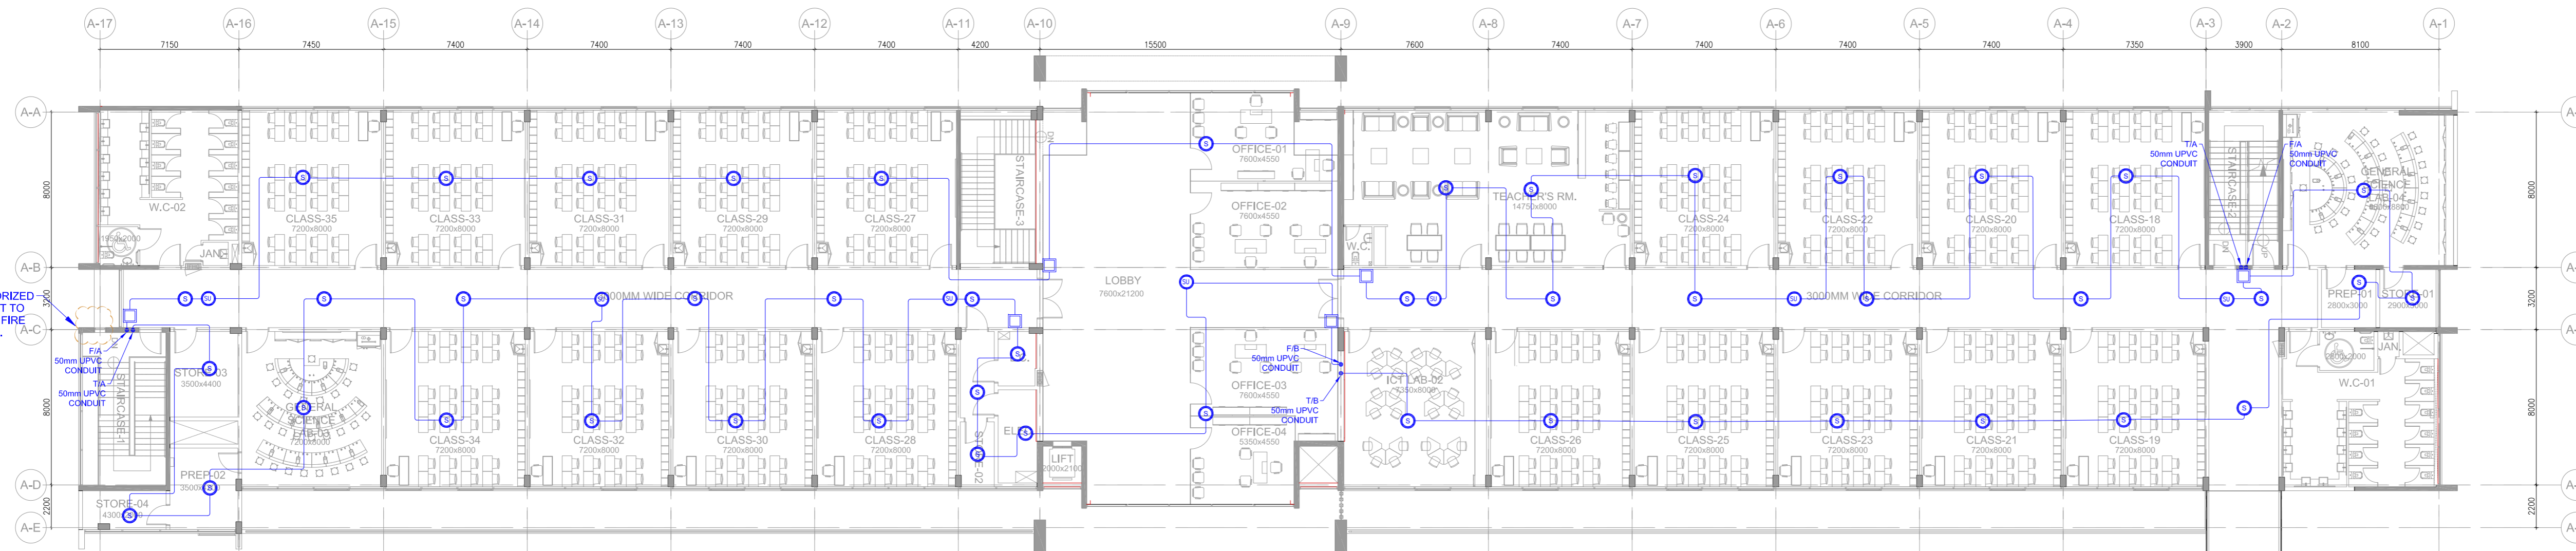


BLOCK A - FIRST FLOOR (PRIMARY BLDG.)
1 : 200

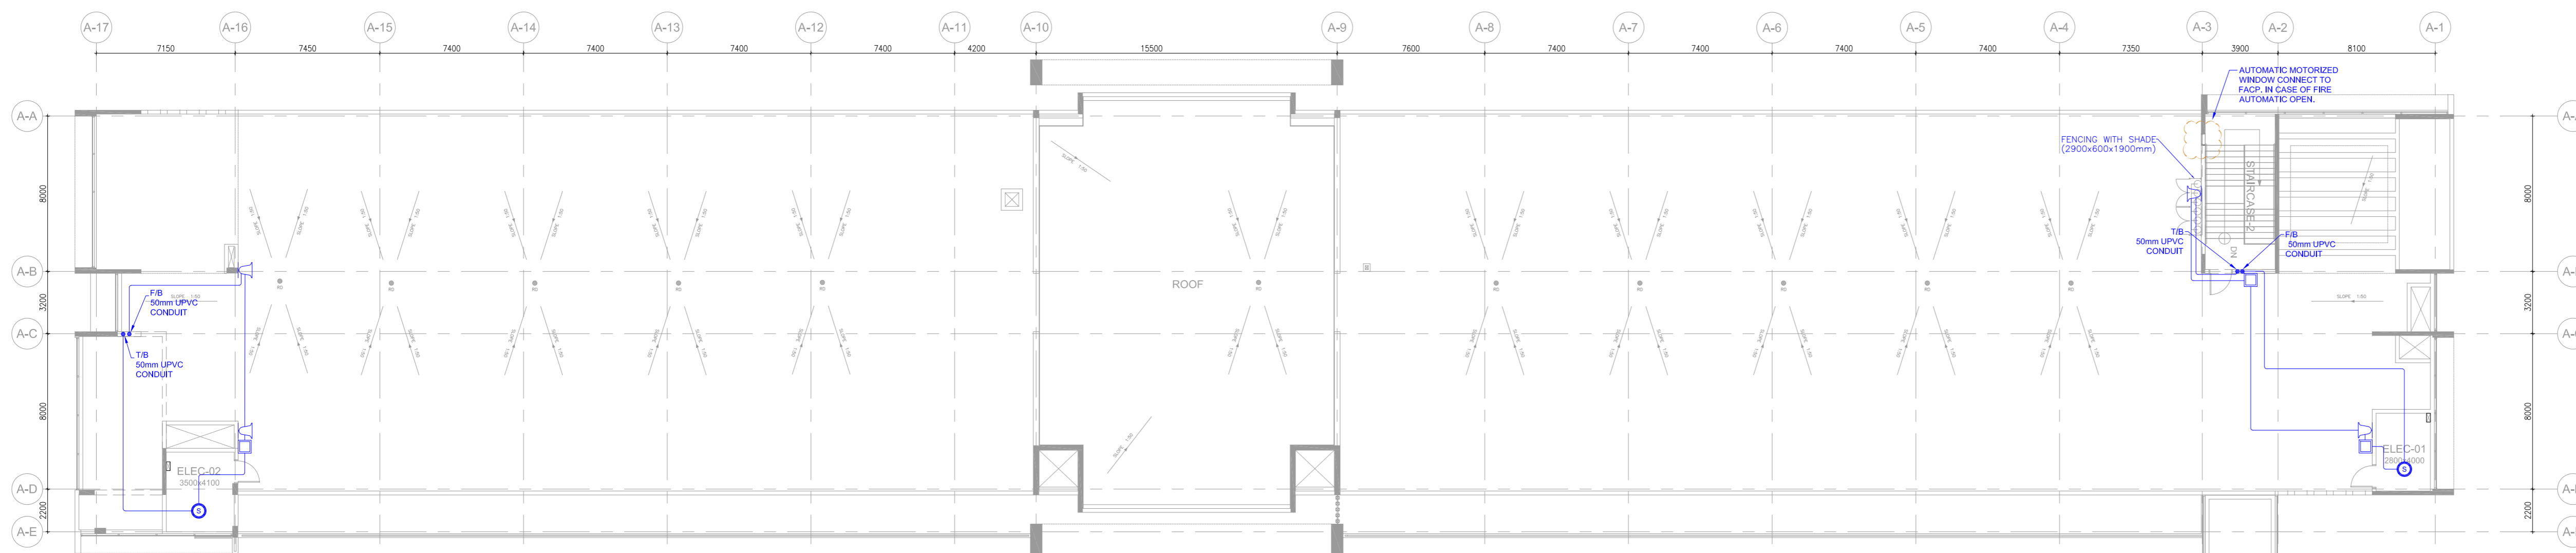

BLOCK A - ROOF FLOOR (PRIMARY BLDG.)
1 : 200

GENERAL NOTES:
 • ALL DIMENSIONS ARE IN MILLIMETRES UNLESS OTHERWISE STATED.
 • DO NOT SCALE THE DRAWING FOLLOW WRITTEN DIMENSIONS ONLY.
 • FOR ALL ABBREVIATION AND SYMBOLS REFER TO SHEET NO. : G-103.

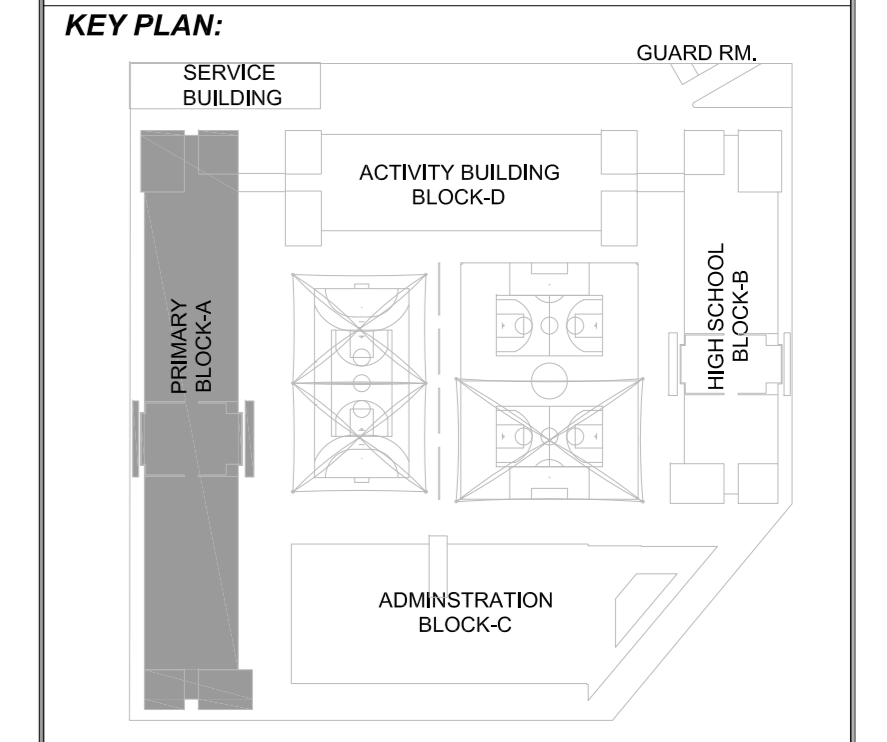

FIRE ALARM SYMBOLS

	SMOKE DETECTOR
	HEAT DETECTOR
	GAS DETECTOR
	ELECTRONIC SOUNDER
	BREAK GLASS
	ALARM BELL
	MODULE
	FIRE ALARM CONTROL PANEL
	FIRE ALARM REPEATER PANEL
	INDICATOR PANEL
	BEAM DETECTOR (TRANSMIT AND RECEIVE)
	BEAM DETECTOR (REFLECTIVE)
	FIRE ALARM WIRE (SMOKE & HEAT DETECTOR)
	FIRE ALARM WIRE (ALARM BELL)

NOTE:
 • MINIMUM ALARM LEVEL 100DB
 • ALL EXTERNAL ACCESSORIES TO BE W/P

A	02-04-20	FIRE ALARM DRAWING REARRANGED AS PER ARCHITECTURAL AMENDMENTS	SIGN
NO.	DATE	REVISION DESCRIPTION	

CONSULTANT
 الاستشاريون للبحوث والتطوير والتخطيط العمراني
Development, Research & Urban Planning Consultants LLC
 DRU
 Tel: +971 9 2249422 Fax: +971 9 2249497 P.O. Box: 3477 Fujairah-UAE
 E-mail: info@drugulf.ae, www.drugulf.ae, www.facebook.com/drucconsultants

PLOT LOCATION
 RUIJ, DIBBA
 DIBBA-FUJAIRAH.

PLOT CODE
 PLOT NO:1403051

CLIENT
 H.H.SHEIKH SALEH BIN MOHAMMED BIN
 HAMAD AL SHARQI

CONTRACTOR
 FUJAIRAH NATIONAL CONSTRUCTION
 TRANSPORT CO.
 FNC
 P.O. BOX 81, FUJAIRAH -U.A.E.
 TEL: (0714) 224 1564 FAX (0714) 223 1272

PROJECT NAME
 G+2 SCHOOL BLDG.-2, PLOT NO.-5001388,
 AL NAHDAH, DIBBA

DRAWING TITLE
 BLOCK A - PRIMARY BUILDING
 FIRE ALARM LAYOUT

PROJECT NO.	DISCIPLINE	CHART NO.	DRAWING STATUS	REV.
1810	E	401A	F	A

ARCHITECT
 J.K.M.

STR. ENGINEER
 A.A.H.

SCALE
 1 : 200

DATE
 THIS DRAWING IS COPYRIGHT TO DRU
 Path: \\server\mah\DRU\1810 Al Deyar School 2-Dibba10 ElectricalA
 Primary Building-401 A (SP) FF 1A.dwg