



**BLOCK A - GROUND FLOOR (PRIMARY BLDG.)**  
1 : 200

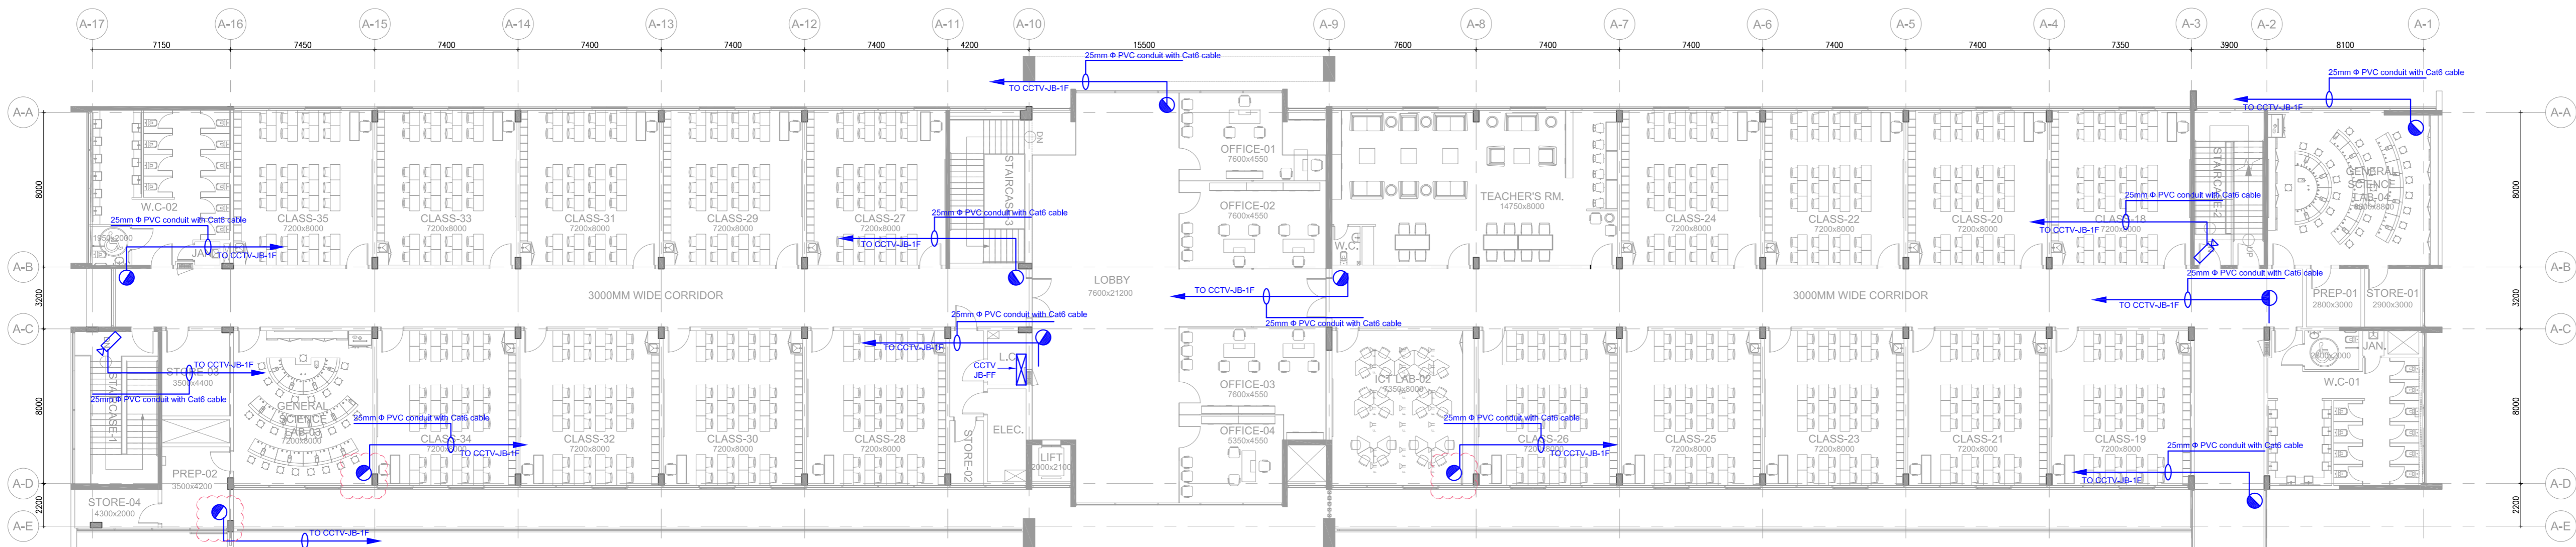


**BLOCK A - FIRST FLOOR (PRIMARY BLDG.)**  
1 : 200

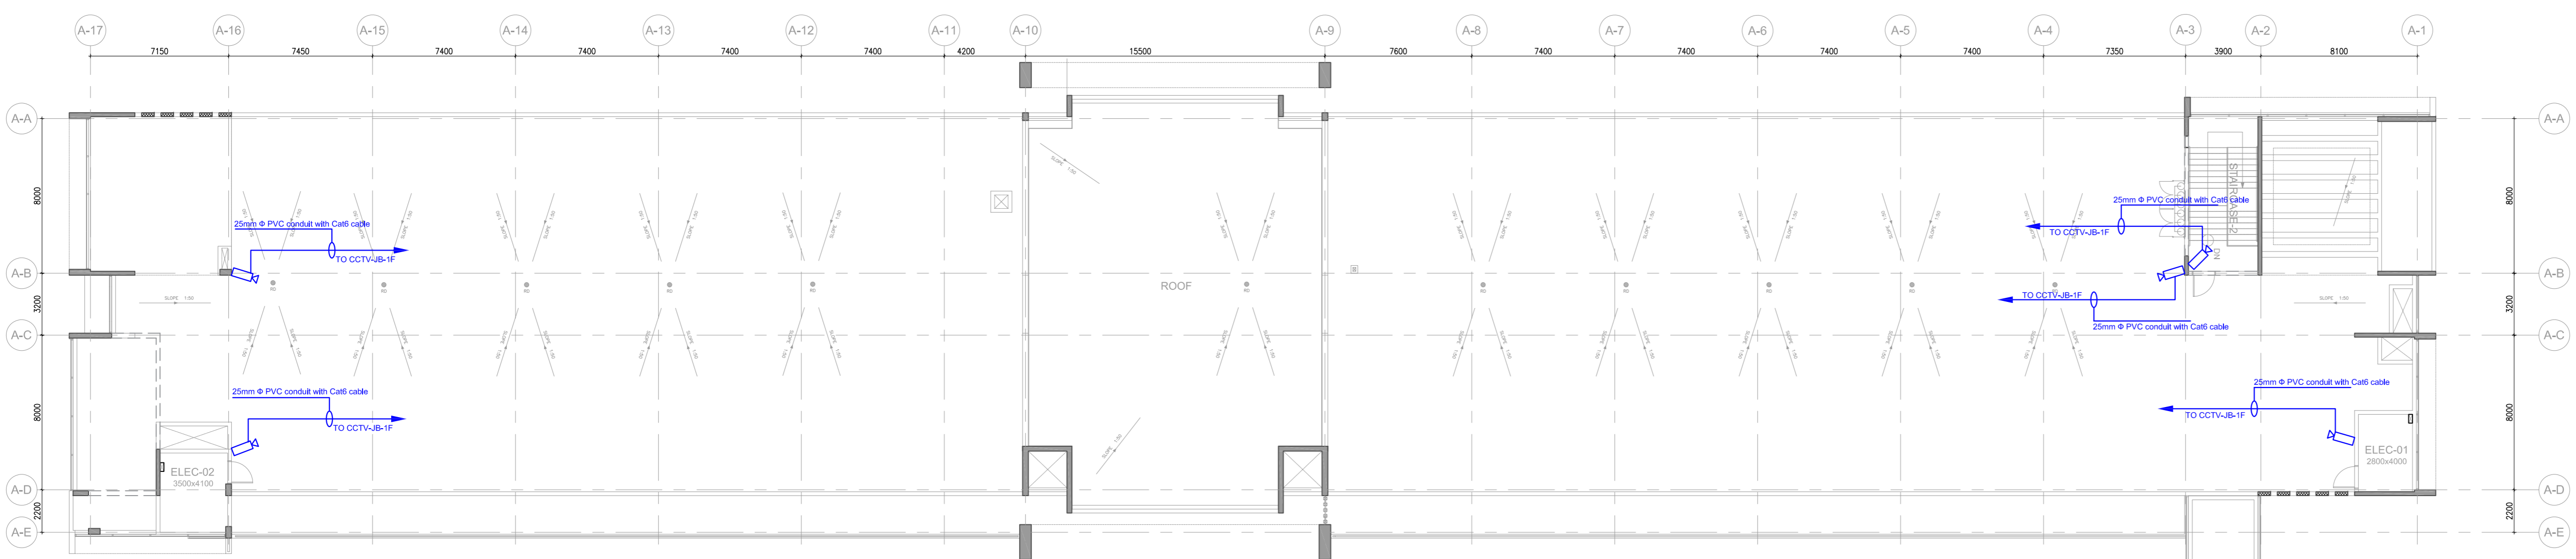

**BLOCK A - ROOF FLOOR (PRIMARY BLDG.)**  
1 : 200

**GENERAL NOTES:**  
 • ALL DIMENSIONS ARE IN MILLIMETRES UNLESS OTHERWISE STATED.  
 • DO NOT SCALE THE DRAWING FOLLOW WRITTEN DIMENSIONS ONLY.  
 • FOR ALL ABBREVIATION AND SYMBOLS REFER TO SHEET NO : G-103.

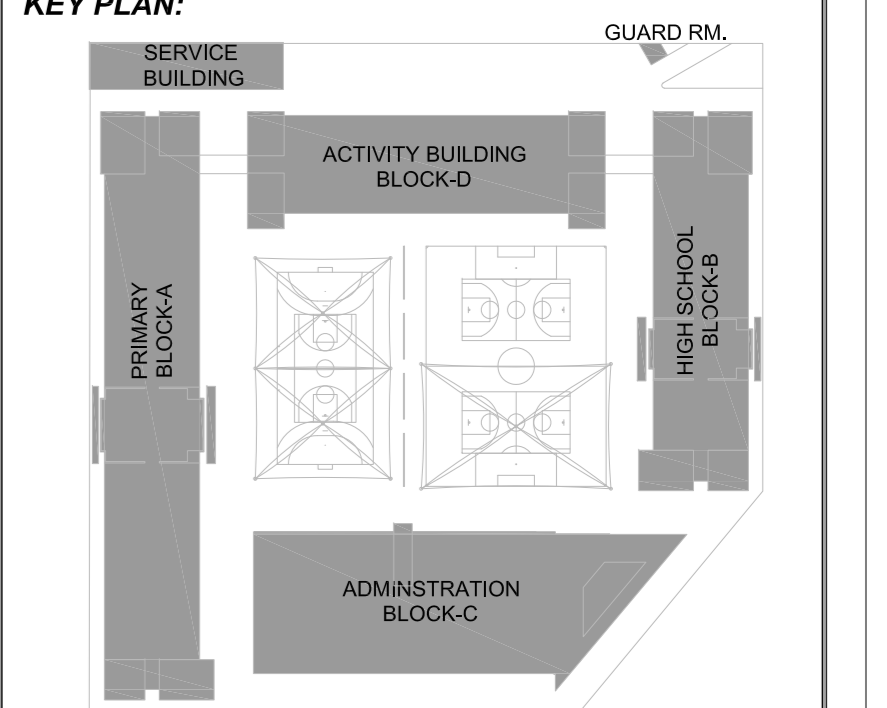

- CCTV SYMBOLS**
- FIXED DOME CAMERA
  - FIXED CAMERA ( WATER PROOF )
  - FACE RECOGNITION CAMERA
  - CAMERA CAR PLATE NUMBER RECOGNITION (A.N.P.R.)
  - CCTV JUNCTION BOX
  - CENTRAL ACCESS CARD READER

D	22-11-20	REMOVE OUTSIDE CAMERA. (REFER TO CCTV SITE PLAN DRAWING FOR THE OUTSIDE CAMERAS).	
C	15-11-20	CCTV DRAWING REARRANGED AS PER REQUESTED ADDITIONAL CAMERAS.	
B	27-05-20	ADDITIONAL CENTRAL ACCESS CARD READER IN SECOND FLOOR.	
A	02-04-20	CCTV DRAWING REARRANGED AS PER ARCHITECTURAL AMENDMENTS.	
NO.	DATE	REVISION DESCRIPTION	SIGN

**CONSULTANT**  
 الاستشاريون للبحوث والتطوير والتخطيط العمراني ذ.م.م  
**Development, Research & Urban Planning Consultants LLC**  
 Tel: +971 9 2249422 Fax: +971 9 2249497 P.O. Box: 3477 Fujairah-UAE  
 E-mail: info@drugulfae.com, www.drugulfae.com, www.facebook.com/drucosultants

<b>PLOT LOCATION</b>	RUL DIBBA DIBBA-FUJAIRAH.	<b>STAMP</b>
<b>PLOT CODE</b>	PLOT NO:1403051	

**CLIENT**  
 H.H.SHEIKH SALEH BIN MOHAMED BIN  
 HAMAD AL SHARQI

<b>MAIN CONTRACTOR</b>	<b>SECURITY CONTRACTOR</b>
FUJAIRAH NATIONAL CONSTRUCTION & TRANSPORT CO.	Al Watan Security Services P.O.Box No: 121 Fujairah, UAE. Tel No: +971 9 2249666 Fax No: +971 9 2249333

**PROJECT NAME**  
 G+2 SCHOOL BLDG.-2, PLOT NO.-5001388,  
 AL NAHDAH, DIBBA

**DRAWING TITLE**  
 BLOCK A - PRIMARY BUILDING  
 CCTV LAYOUT

<b>PROJECT NO.</b>	<b>DISCIPLINE</b>	<b>CHART NO.</b>	<b>DRAWING STATUS</b>	<b>REV.</b>
1810	E	701A	F	D

**ARCHITECT** J.K.M.  
**STR. ENGINEER** A.A.H.

**SCALE** 1 : 200 **DATE**

THIS DRAWING IS COPYRIGHT TO DRU  
 PLOT: Eneer/Mah-ER01810 Al Qayr School 2-Dibba10 ElectricalA  
 Primary Bldg(E-701 A) GF FF CCTV.dwg